

120'-0"

42"

F.F. ELEVATION 897'-10"

TOTAL Φ 7200
120'x60'

12x12 OVERHEAD
DOOR

6'
12'
42"

30'

30'

2 HOUR
FIRE WALL

42"x7'

3'-0"x7'-0"

2'-0"x7'-0"

BREAK
Rm

BATH
Rm

2 HOUR
FIRE WALL

OFFICE

3'-0"x7'-0"

3'-0"x7'-0"

OFFICE

10'
REST
Rm

OFFICE

ENTRY
HALL

HALL

10'

OFFICE

42" DOOR

PORCH



6'

55'


FLOOR PLAN

POST & BEAM STRUCTURE
29 G. STEEL SIDING
29 G. STEEL ROOFING

JACKSON CONSTRUCTION
LLC. KADISON IN.
SCALE 1" = 10'-0"
DRAWN BY JPIETE

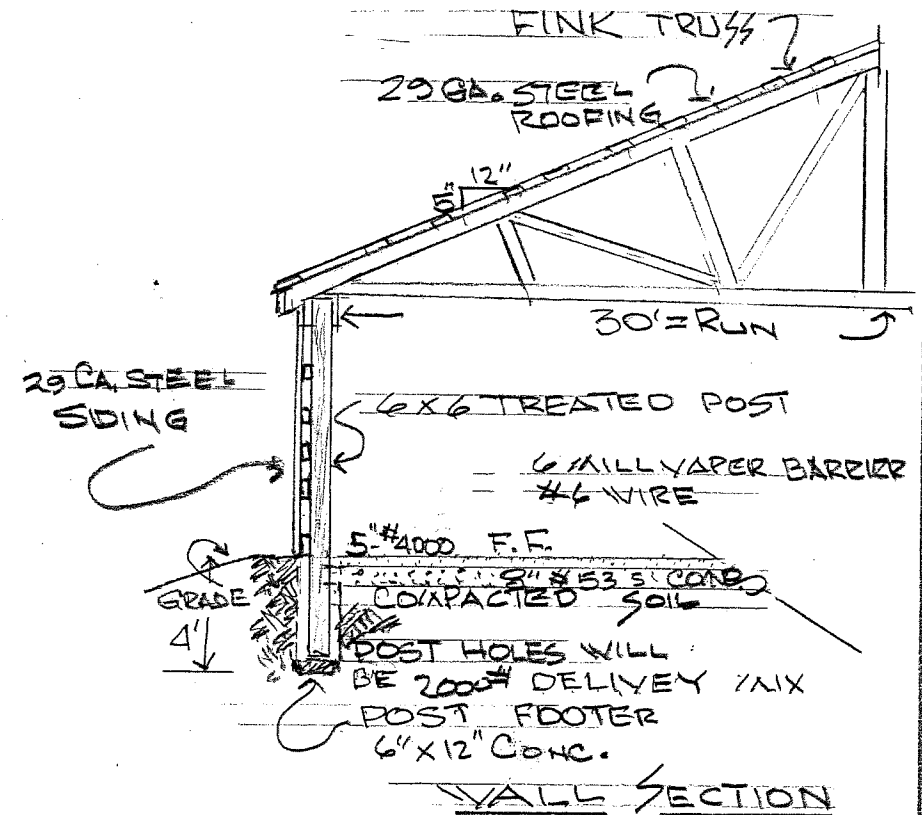
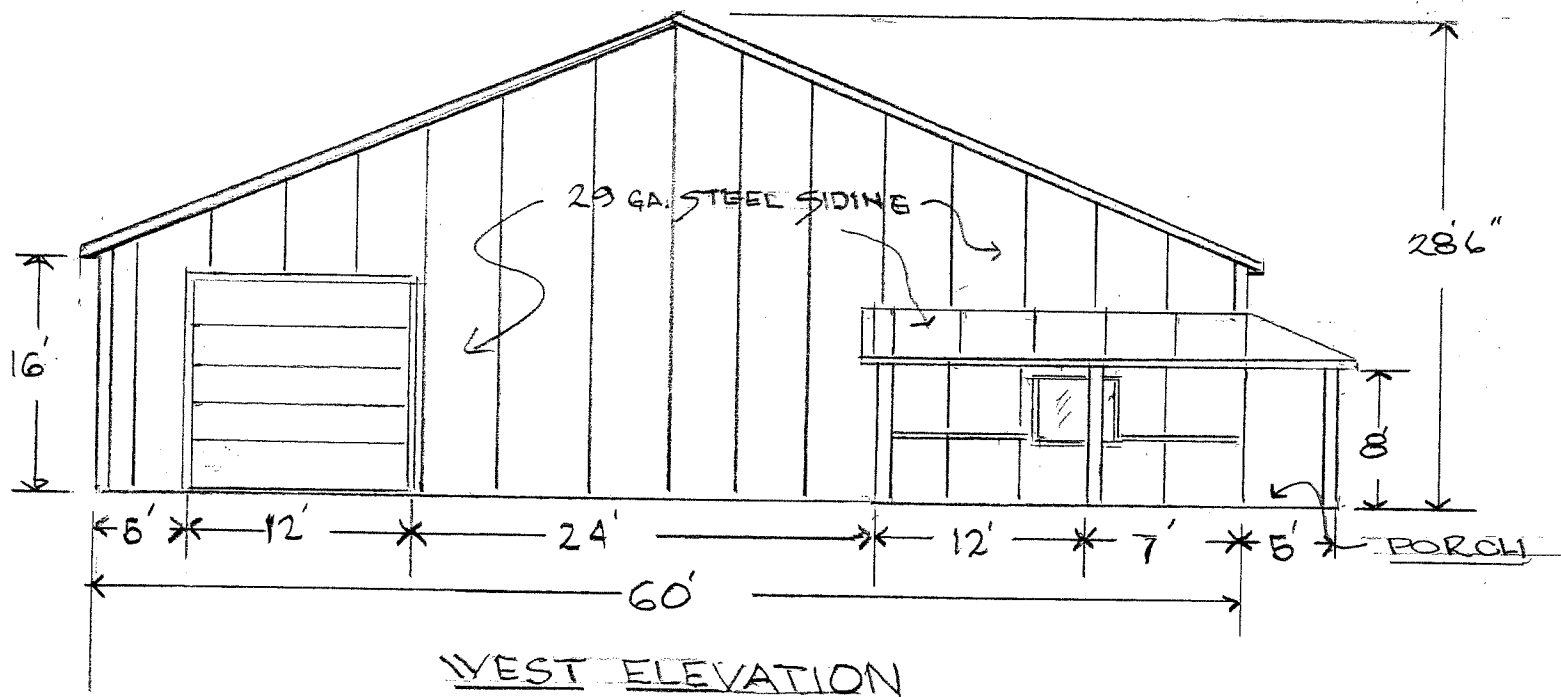


OWNER JACKSON CONSTRUCTION LLC
 MADISON IN. SCALE 1"=10'-0"
 DRAWING BY J. PETE

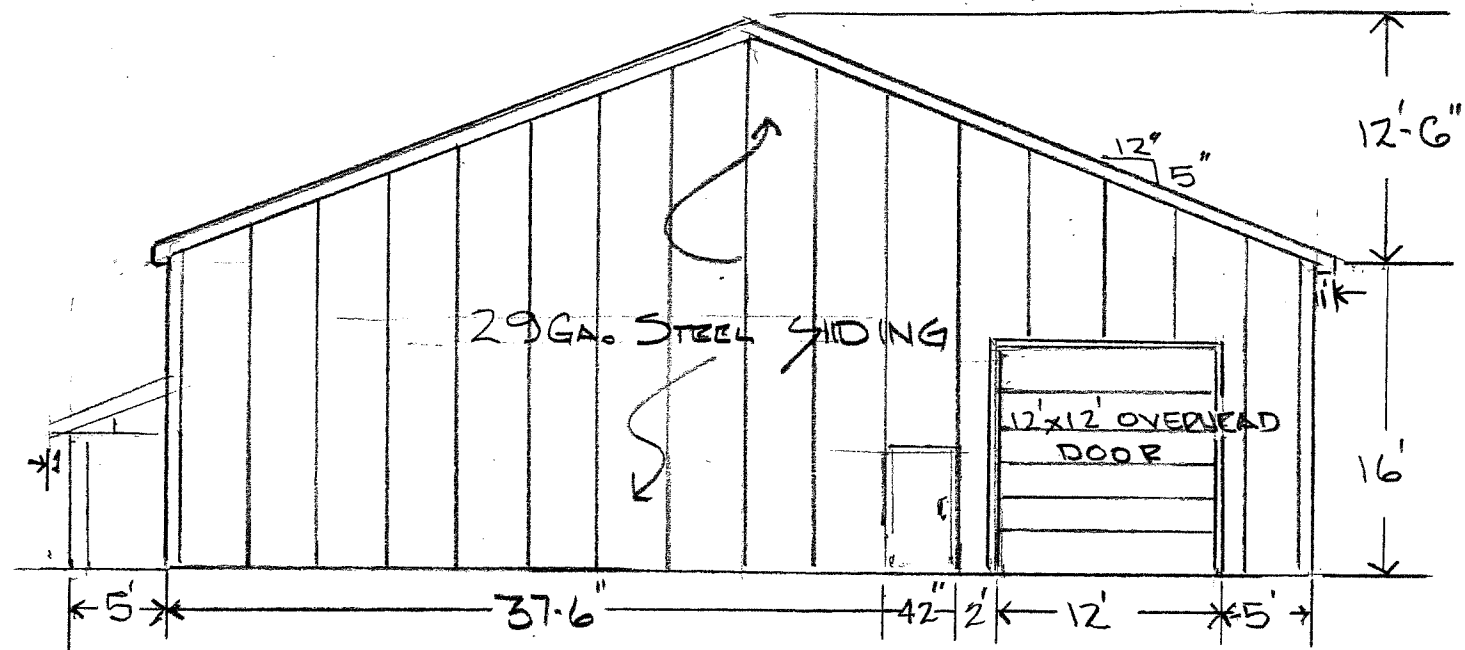


EAST ELEVATION

OWNER JACKSON CONSTRUCTION LLC.
MADISON IND.
SCALE 1"=10'-0" DRAWING BY JPETE

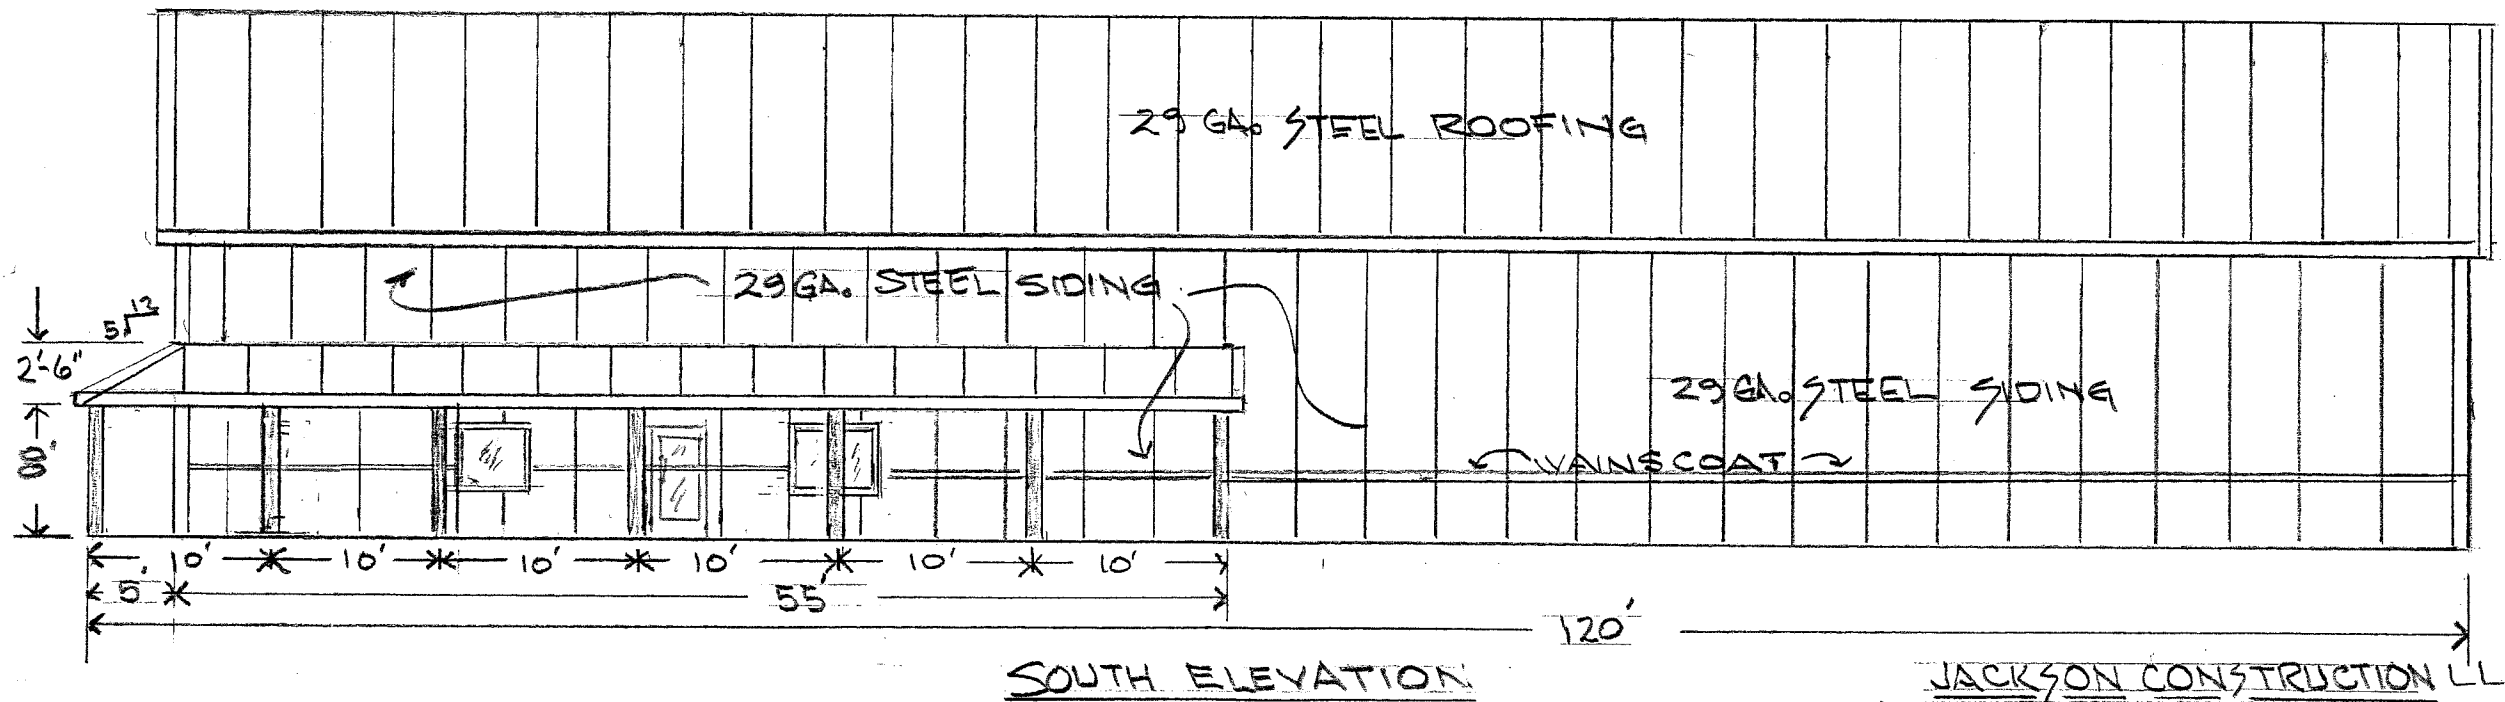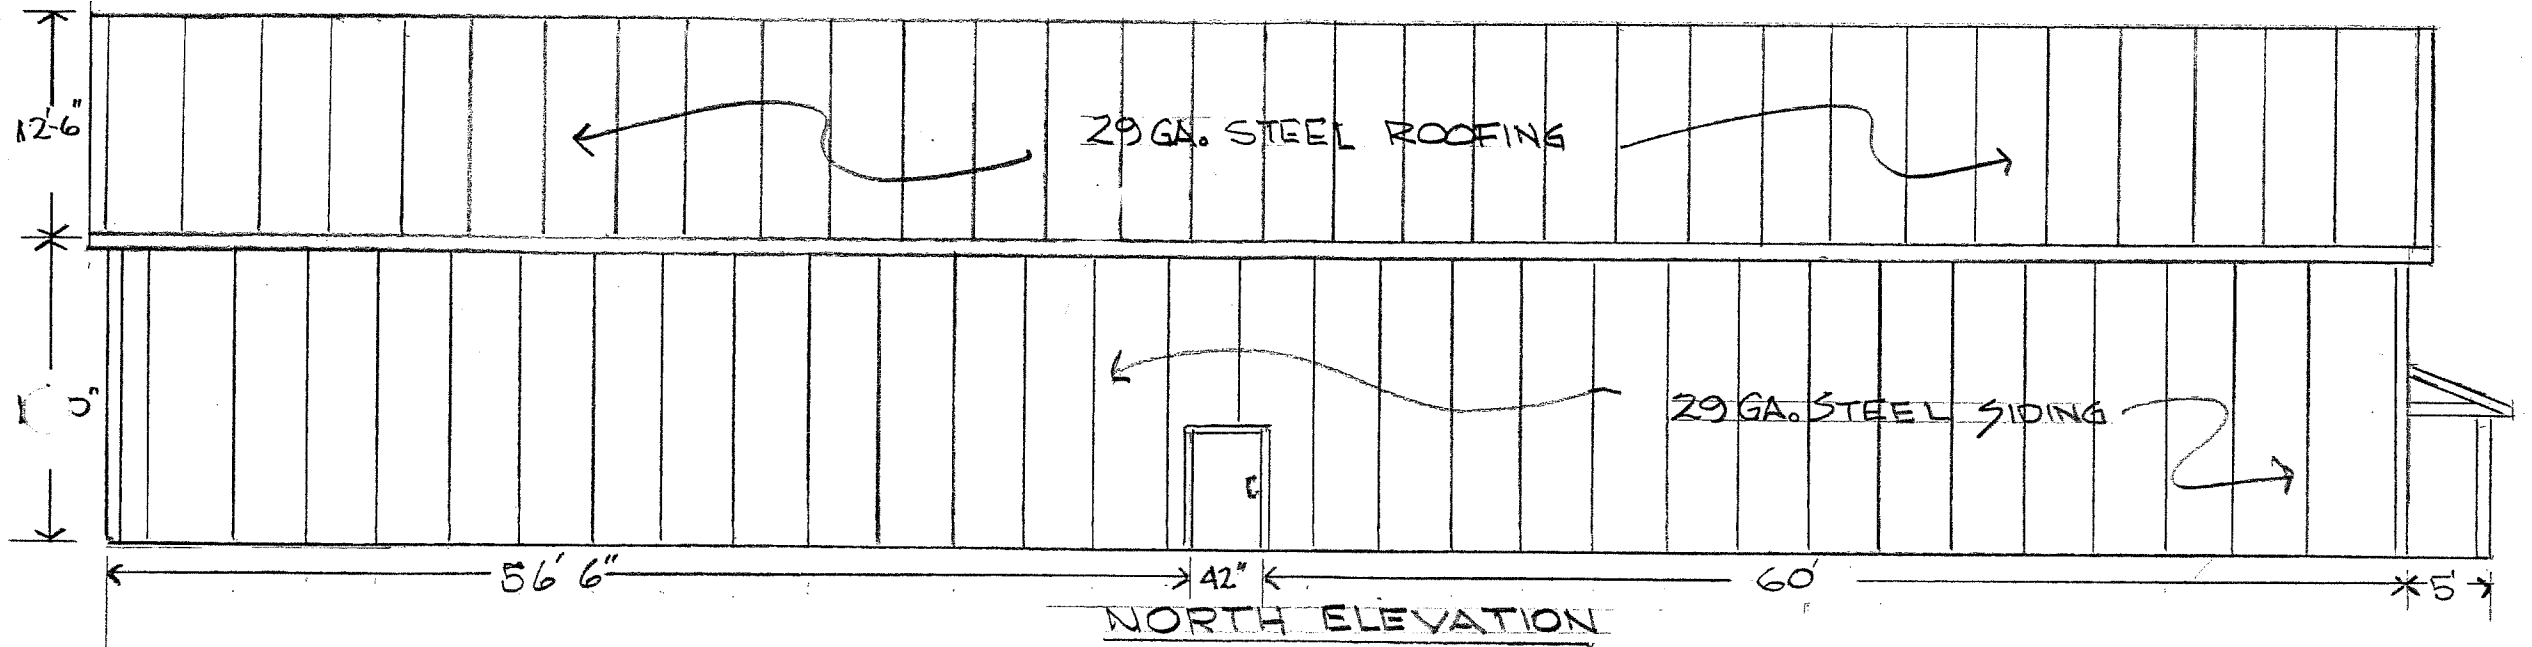

JACKSON CONSTRUCTION LLC.
MADISON IND.
SCALE 1"=10'-0" DRAWING BY JATE

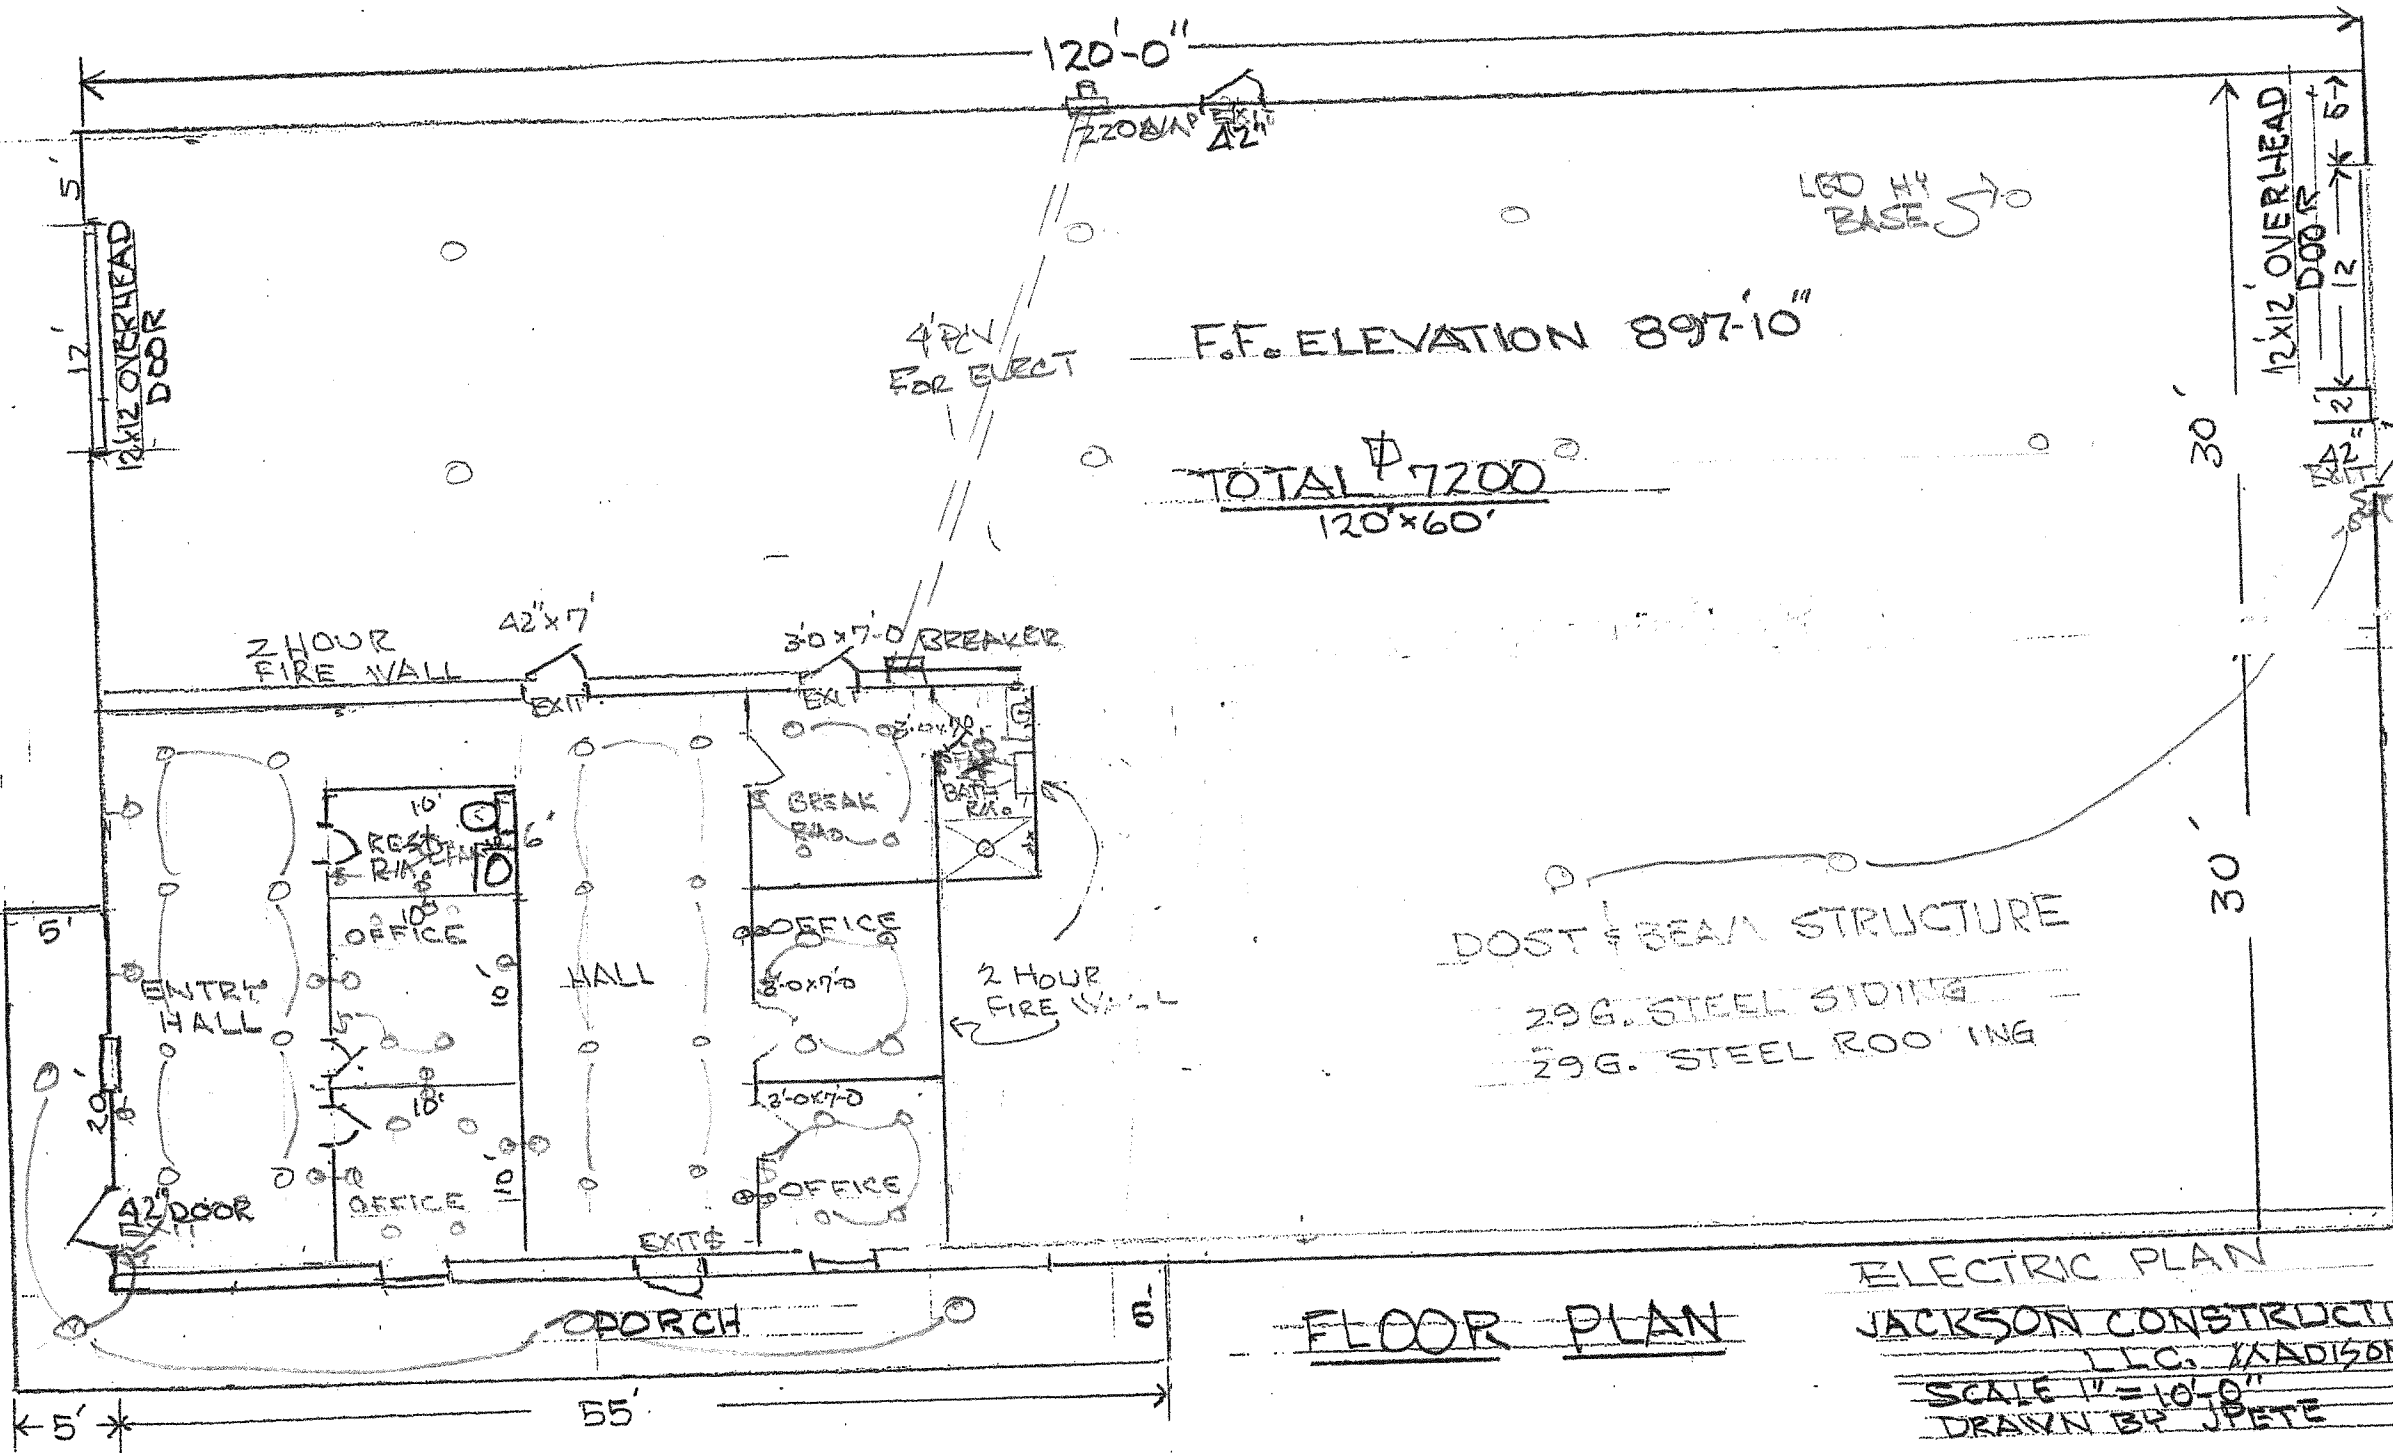


F.F. ELEVATION 897'-10"

TOTAL Φ 7200'
120'x60'

POST & BEAM STRUCTURE
29 G. STEEL SIDING
29 G. STEEL ROOFING

FLOOR PLAN

ELECTRIC PLAN
JACKSON CONSTRUCTION
LLC, MADISON IN.
SCALE 1" = 10'-0"
DRAWN BY J. PETE

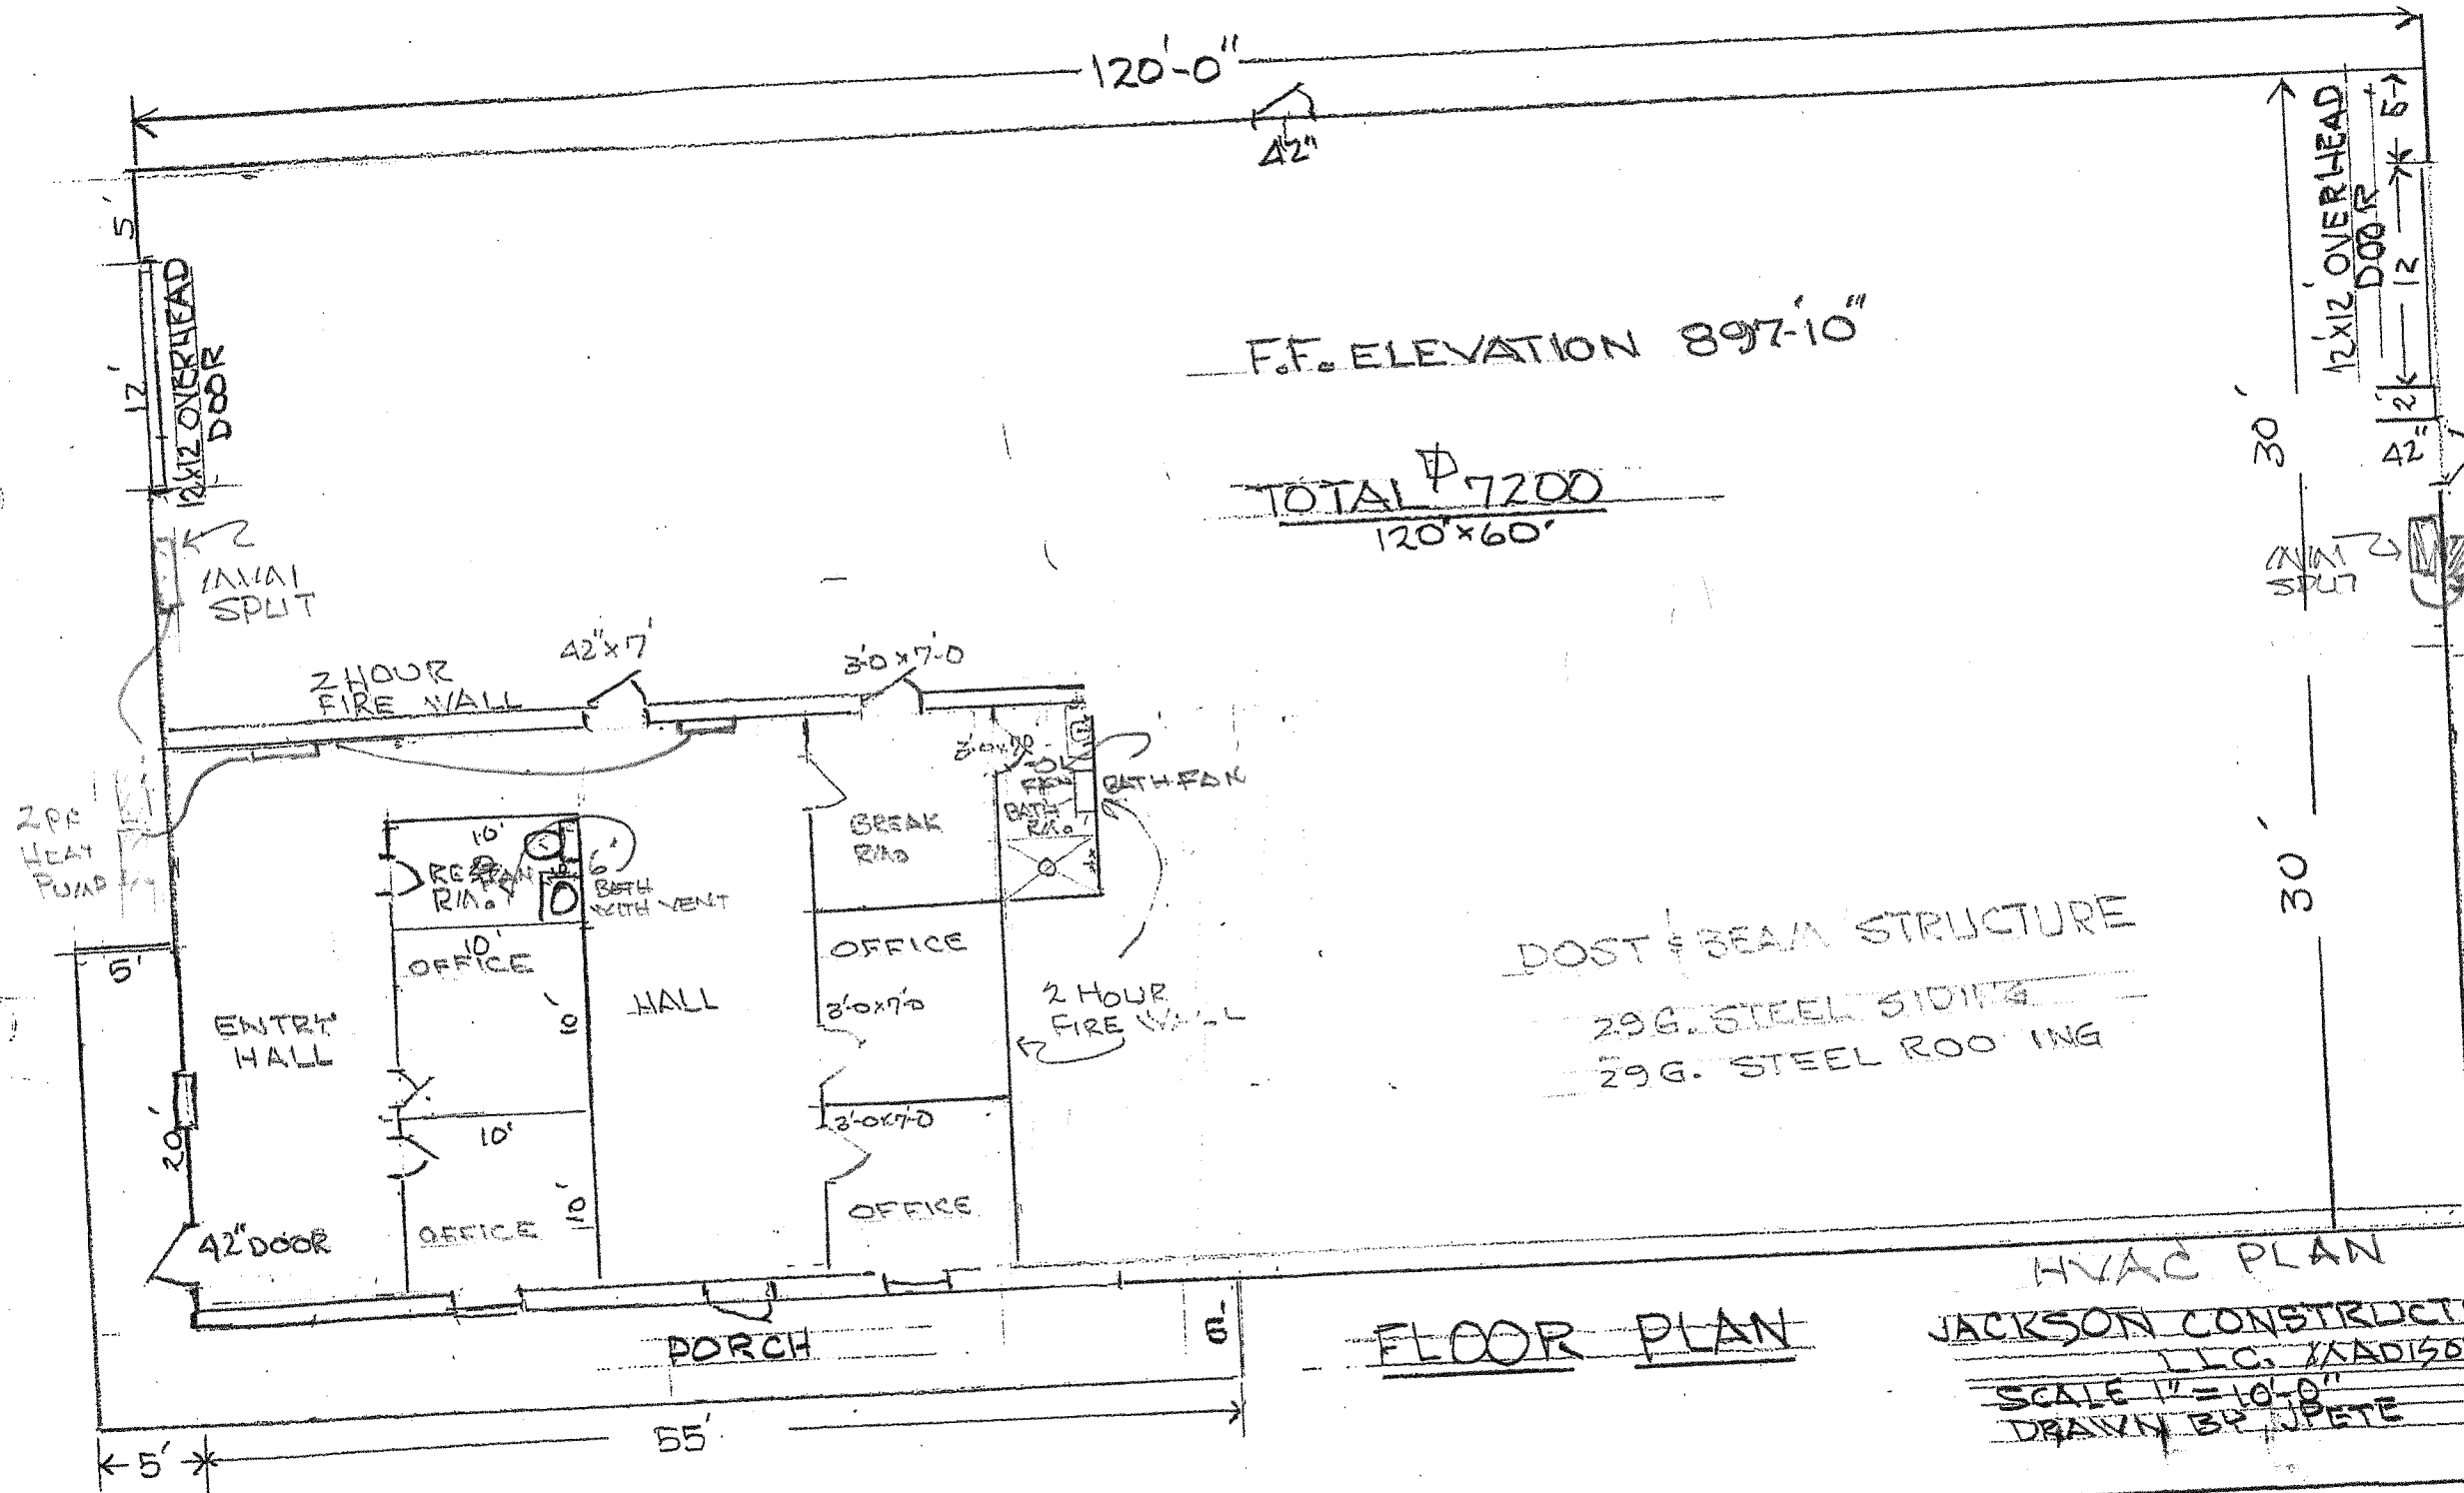

FLOOR PLAN

HVAC PLAN
JACKSON CONSTRUCTION
LLC, KADISON, IN.
SCALE 1" = 10'-0"
DRAWN BY JPETE

120'-0"

42"

F.F. ELEVATION 897'-10"

TOTAL \$ 7200
120'x60'

12x12 OVERHEAD
DOOR

5'-0"
12'-0"
42"

30'
30'

2 HOUR
FIRE WALL

42"x7'

3'-0"x7'-0"

VALVE FOR LINE CLEAN OUT

3" PVC

10'
REST
Rm.

10'
OFFICE

HALL

BREAK
Rm.

OFFICE

3'-0"x7'-0"

2 HOUR
FIRE WALL

3'-0"x7'-0"

OFFICE

1/2
Pex

ENTRY
HALL

42" DOOR

OFFICE

PORCH

POST & BEAM STRUCTURE

29 G. STEEL SIDING

29 G. STEEL ROOFING

FLOOR PLAN

PLUMBING PLAN
JACKSON CONSTRUCTION
LLC, MADISON, IN.
SCALE 1"=10'-0"
DRAWN BY J. PETE

TO CITY
LINE TAP

TO LAT HOOK UP CITY